



ADDENDUM – 1

January 16, 2019


KENNEDY MANOR WASTE LINE REPLACEMENT LOBBY AREA

Project Site:
175 Broad Street, Pawtucket RI 02860

Prepared For:
The Pawtucket Housing Authority

The following changes, modifications, and clarifications are hereby made to the plans and specifications for the above referenced project.

Item 1: Please disregard the waste line replacement for the area located within the electrical room, this area has been removed from the scope of work. Please see attached revised plans.

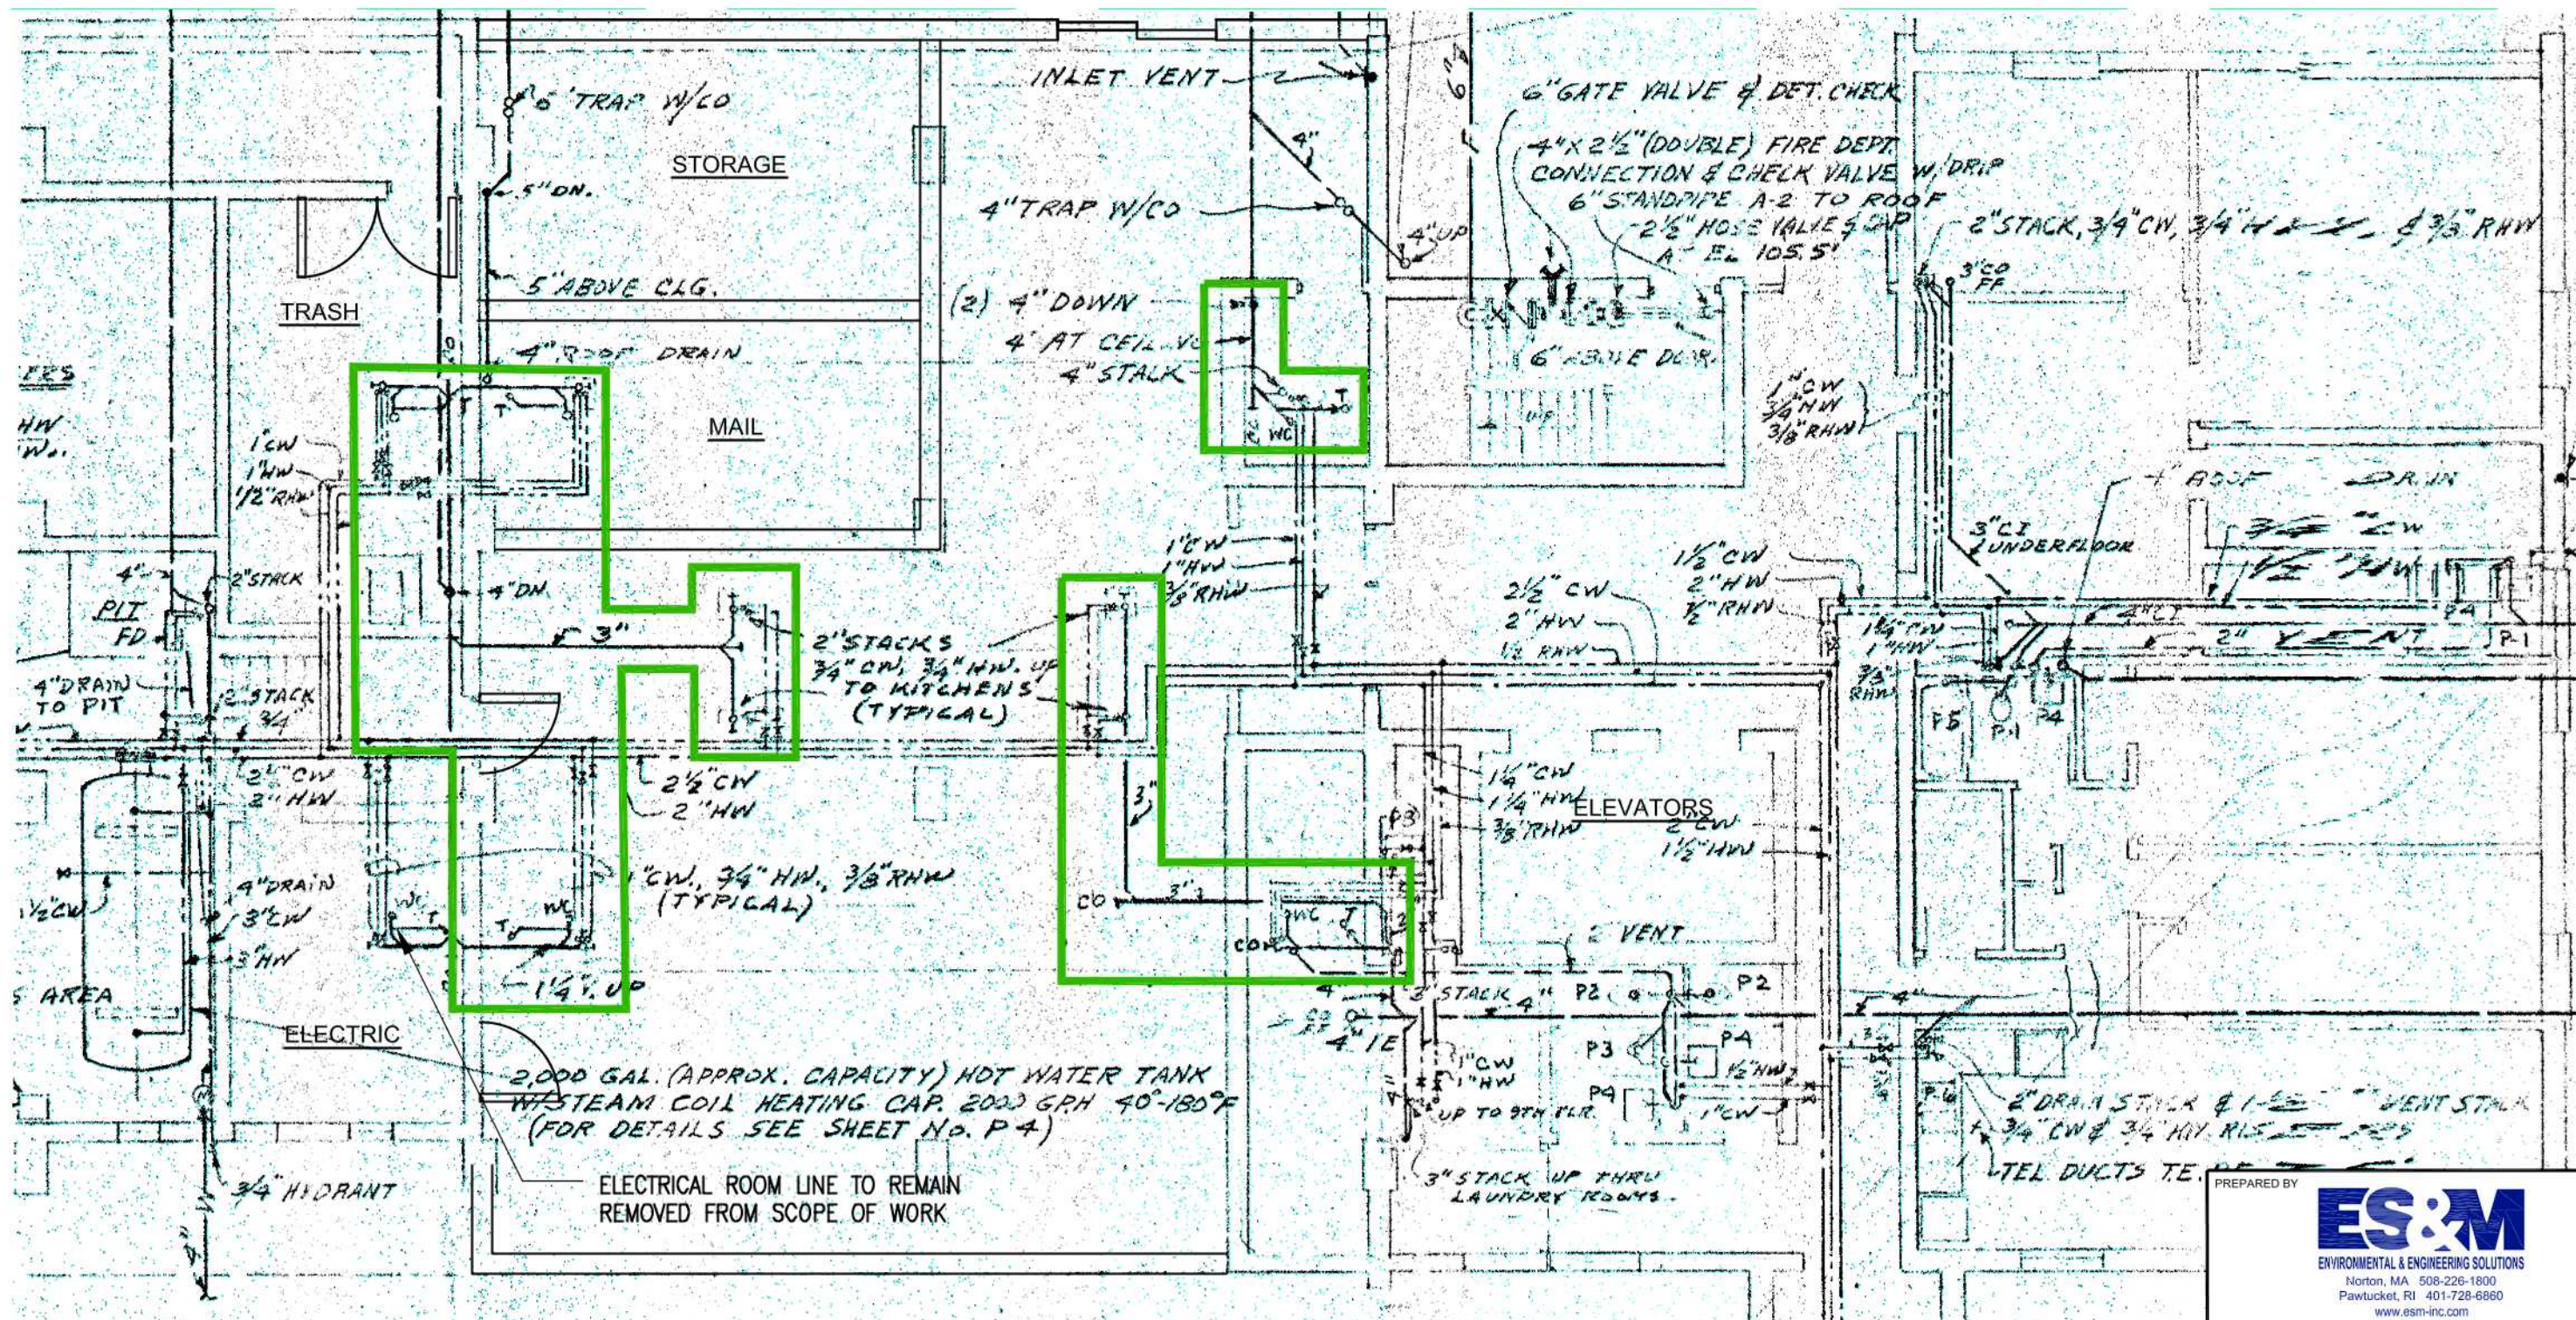


NOTES

1. EXISTING CAST IRON SANITARY SEWER PIPES TO BE REPLACED IN-KIND FOR ALL HORIZONTAL AND VERTICAL LINES.
2. ALL LINES TO BE FLUSHED PRIOR TO REPLACEMENT.

SCALE: 1/8" = 1'-0"

PREPARED BY



ES&M
ENVIRONMENTAL & ENGINEERING SOLUTIONS
Norton, MA 508-226-1800
Pawtucket, RI 401-728-6860
www.esm-inc.com

PREPARED FOR
PAWTUCKET HOUSING AUTHORITY
ROOSEVELT AVENUE
PAWTUCKET, RI

SHEET TITLE
KENNEDY MANOR
LOWER LEVEL PLUMBING PLAN